



NOTES:

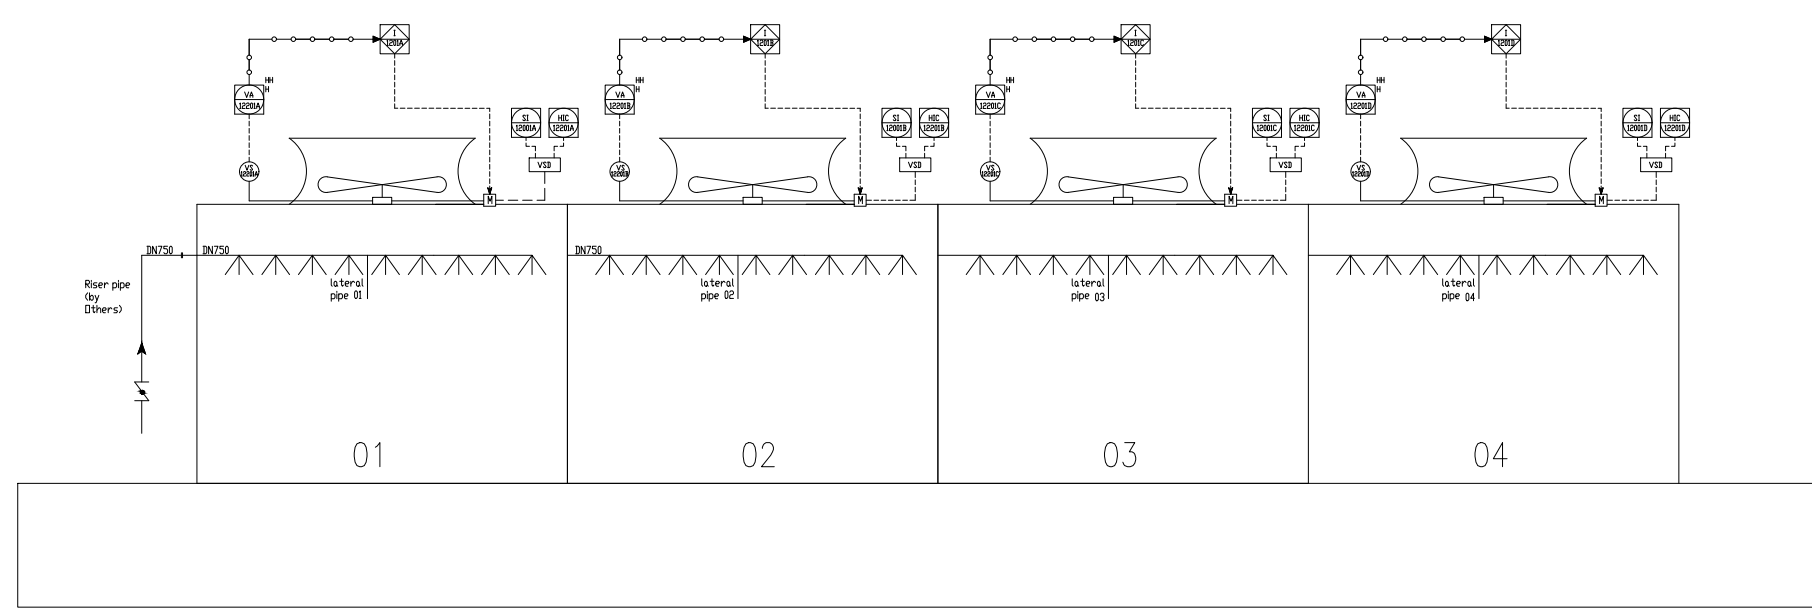

- VS XXXX ————— VIBRATION SWITCH
- ZSD XXXX ————— POSITION/UNIT SWITCH OPEN
- II XXXX ————— DCS LOGIC FUNCTION

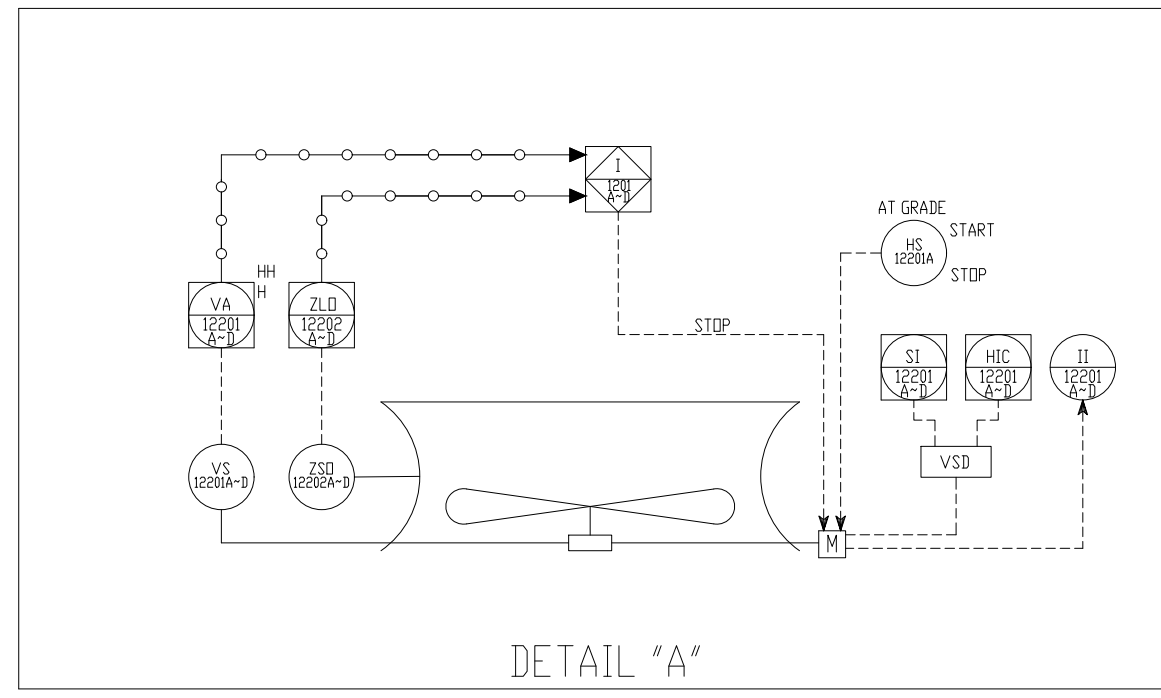

Document Approval Status	
1. REVIEWING & COMMENTING OF THE RESULT BY CONTRACTOR(ONLY)	
2. REFLECT THE RESULT TO THE NEXT SUBMIT	
Approval Status	Issue Purpose : IFA, IFR, IFI, FNL, ASB ()
A	- APPROVED
AAN	- APPROVED WITH COMMENTS (Re-submit)
N/A	- NOT APPROVED (Reject and re-submit fully)
INFO	- INFORMATION ONLY
SIGNED BY :	DATE :

CONTRACTOR permission to proceed or review taken on Vendor document shall not relieve Vendor from its responsibilities or liabilities under the Purchase Order (PO).

REV.	DATE	DESCRIPTION	DRAWN	CHK'D	APP'L	APP'L
B	2018.12.31	ISSUE FOR APPROVAL	CH.LAM	EC.LIM	ZH.YANG	
A	2018.11.22	ISSUE FOR APPROVAL	AY.LOKE	EC.LIM	ZH.YANG	

CLIENT
 HYOSUNG
 HYOSUNG VINA CHEMICALS CO., LTD.

CONTRACTOR
 eTEC E&C Limited
 We build your dream

VENDOR
 Seagull

PROJECT NAME
 HSVCI PP4 PROJECT

TITLE
 Cooling Tower P&ID

P.O. NO. PP4-ME-130 DWG. NO. VP-PP4-ME-130-CT-1201-0701 REV. NO. CT-1201